


Existing Basement

SCALE: 0.1500" = 1'-0"

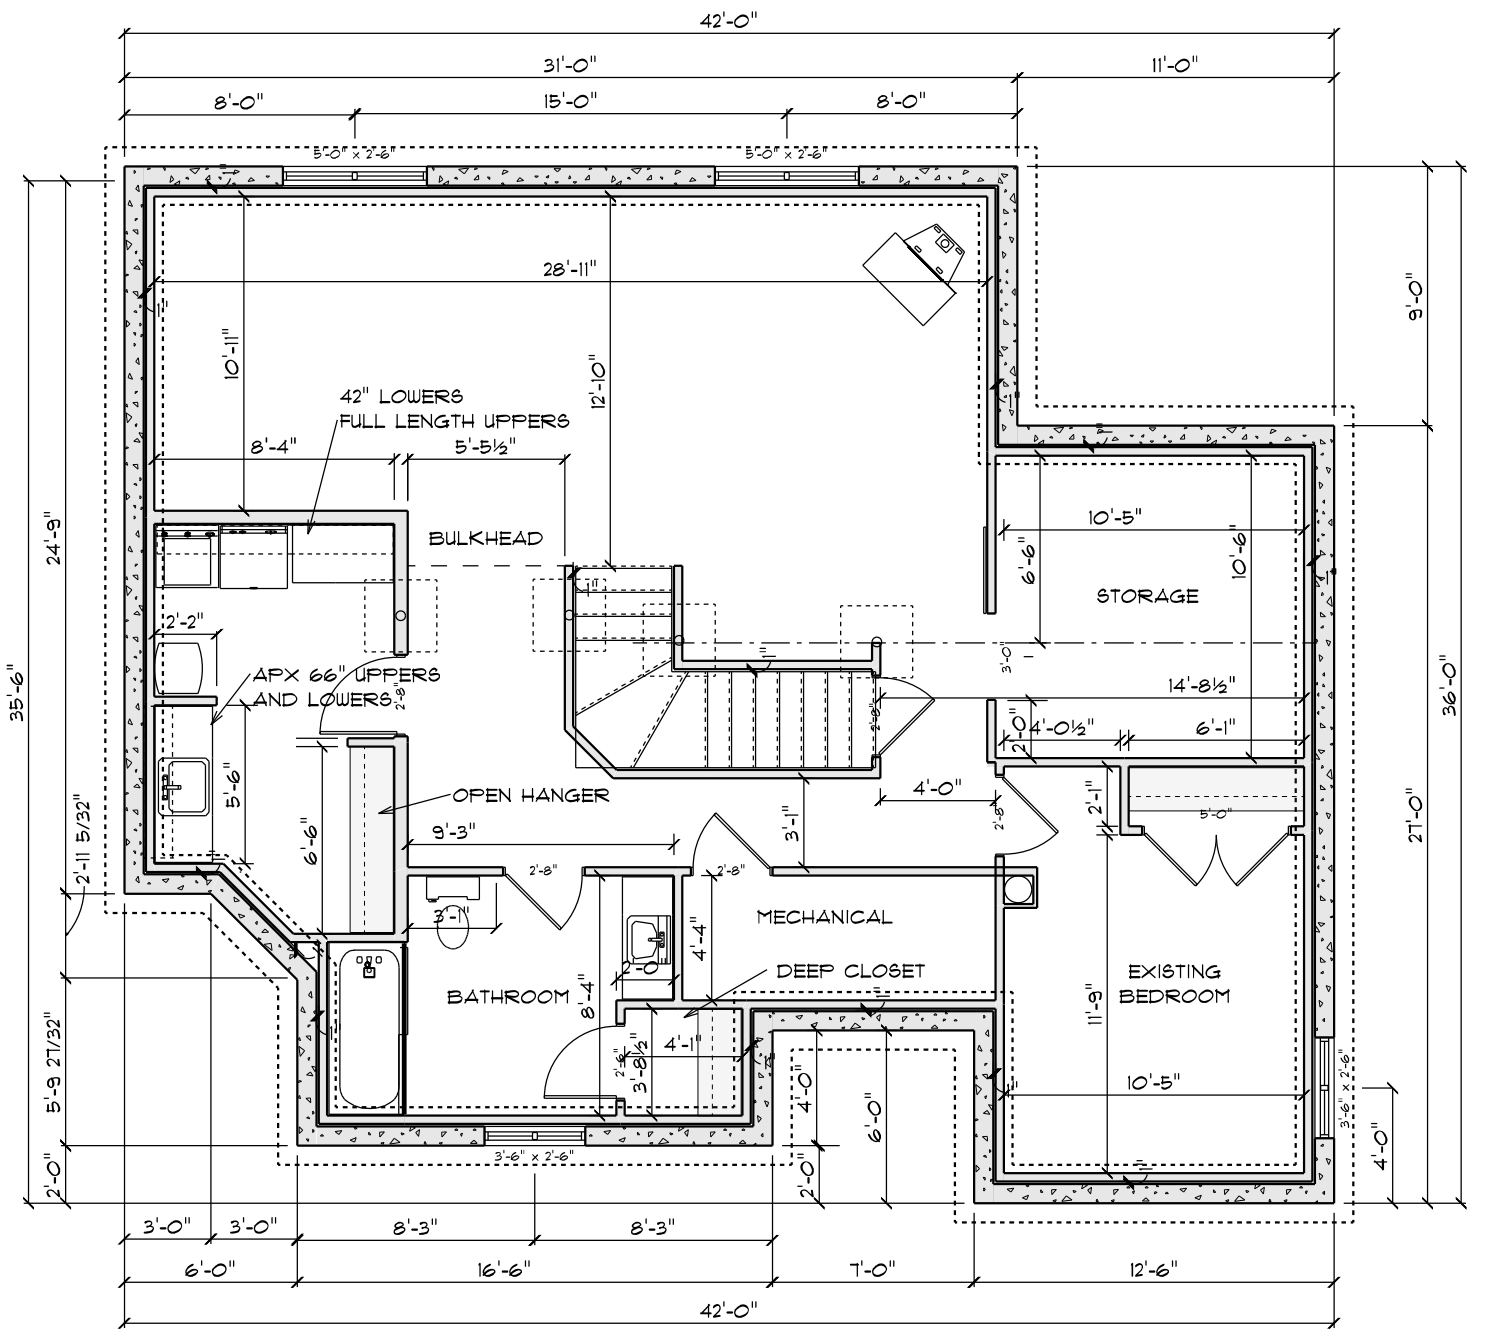

Basement Renovation


SCALE: 0.1500" = 1'-0"



HIVE DG

126 Maple St
Morden
MB
R6M 1H4

PHONE: 204-823-0929
FAX:
james.fh@gmail.com

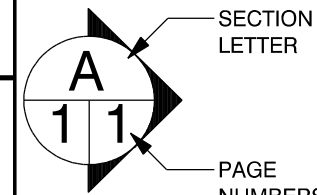


John and Deb Loewen

PHONE:
FAX:

DRAWN BY:
SCALE: 0.1500" = 1'-0"
DATE: 9-Nov-21

PAGE:
1/2
Existing Floor Plan

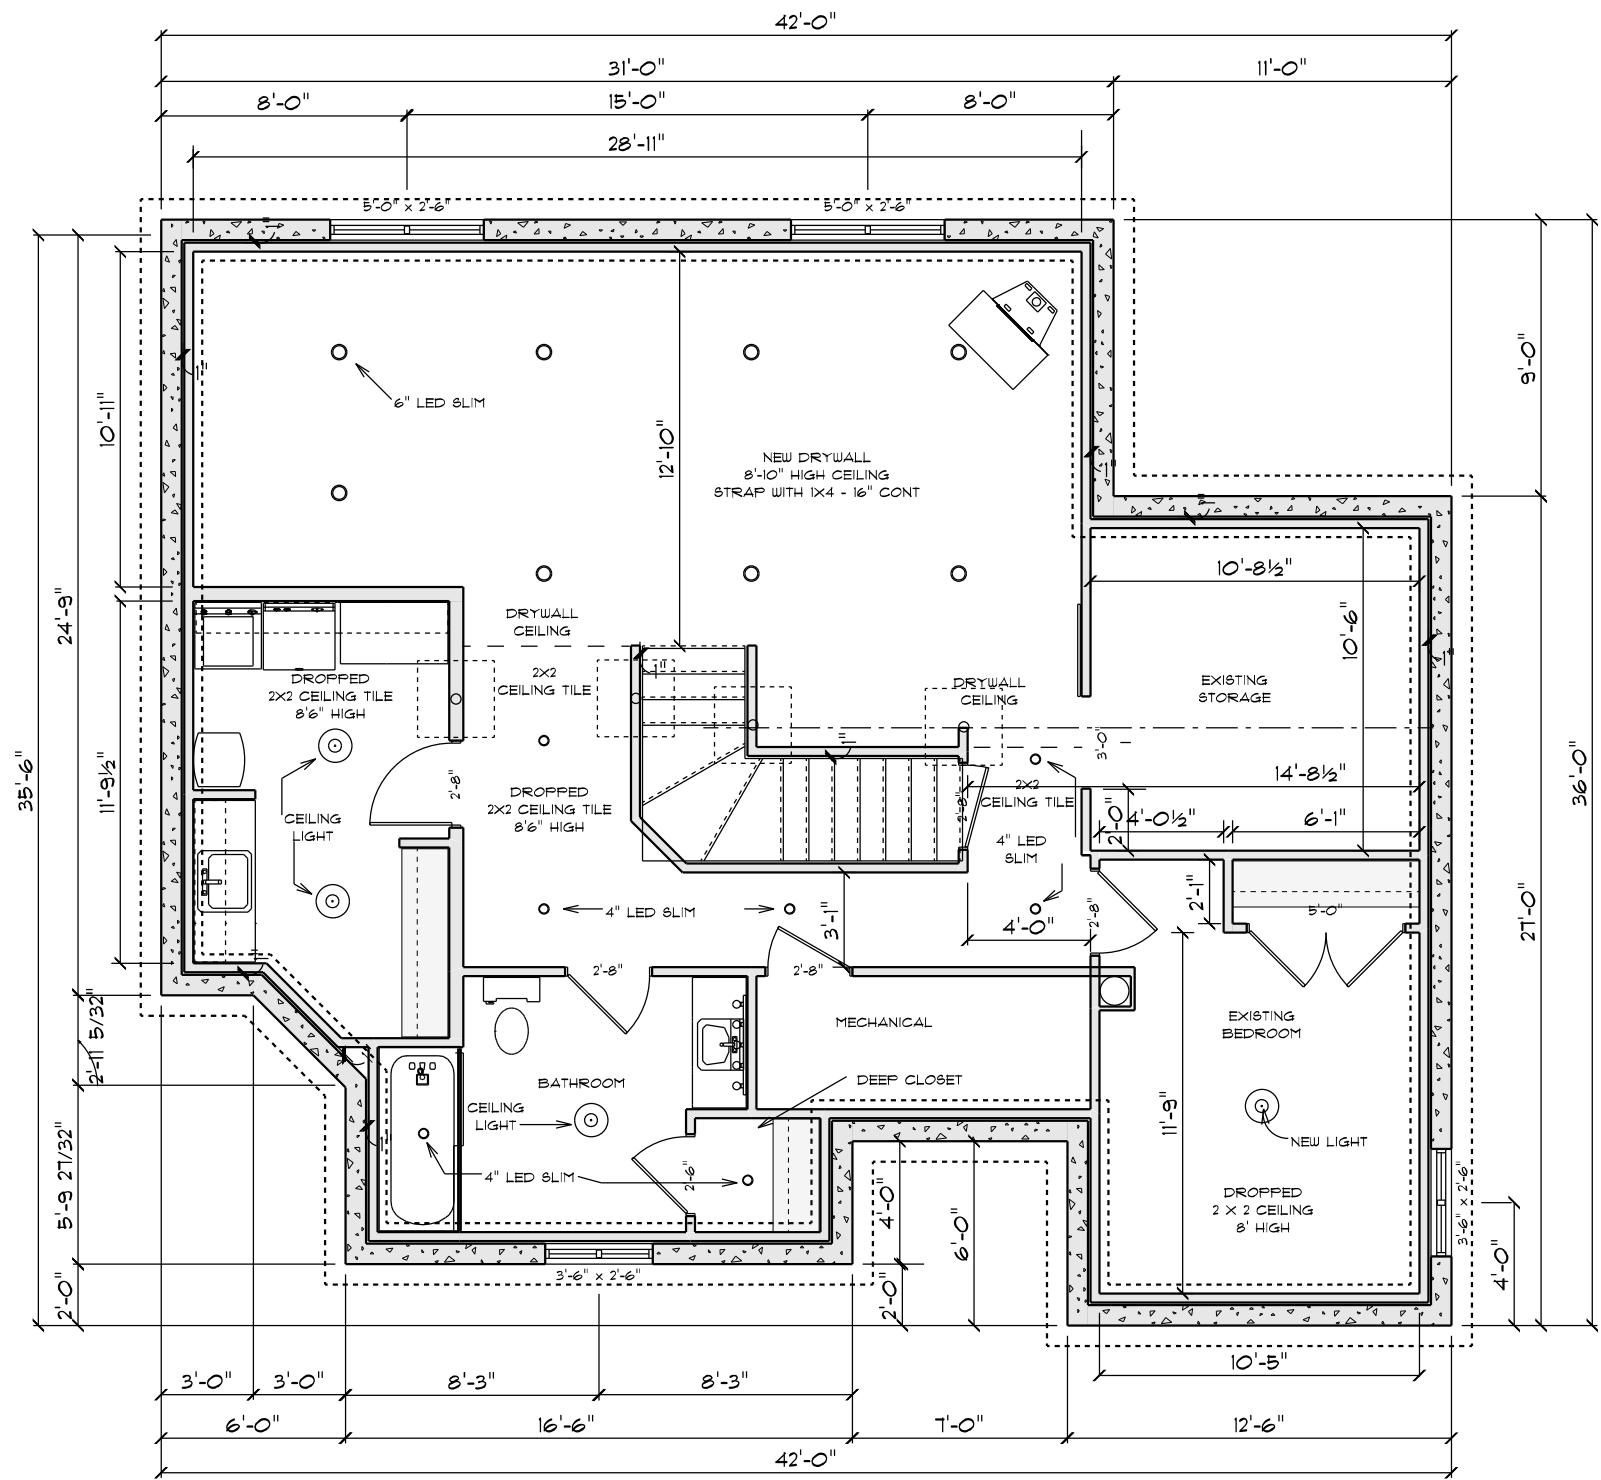

- 8 - 6" SLIM LED
- 1 - 4" SLIM LED
- ⊙ 4 - CEILING LIGHT
- 1 - VANITY WALL LIGHT

Electrical Plan
 SCALE: 0.1600" = 1'-0"

SOFTPLAN
 ARCHITECTURAL DESIGN SOFTWARE

HIVE DG

126 Maple St
 Morden
 MB
 R6M 1H4

PHONE: 204-823-0929
 FAX: james.fh@gmail.com

SECTION LETTER
A

PAGE NUMBERS
1 / 1

John and Deb Loewen
 PHONE:
 FAX:

DRAWN BY:
 SCALE: 0.1600" = 1'-0"
 DATE: 9-Nov-21

PAGE:
2 / 2
 Electrical Plan